


SEE SHEET C-2

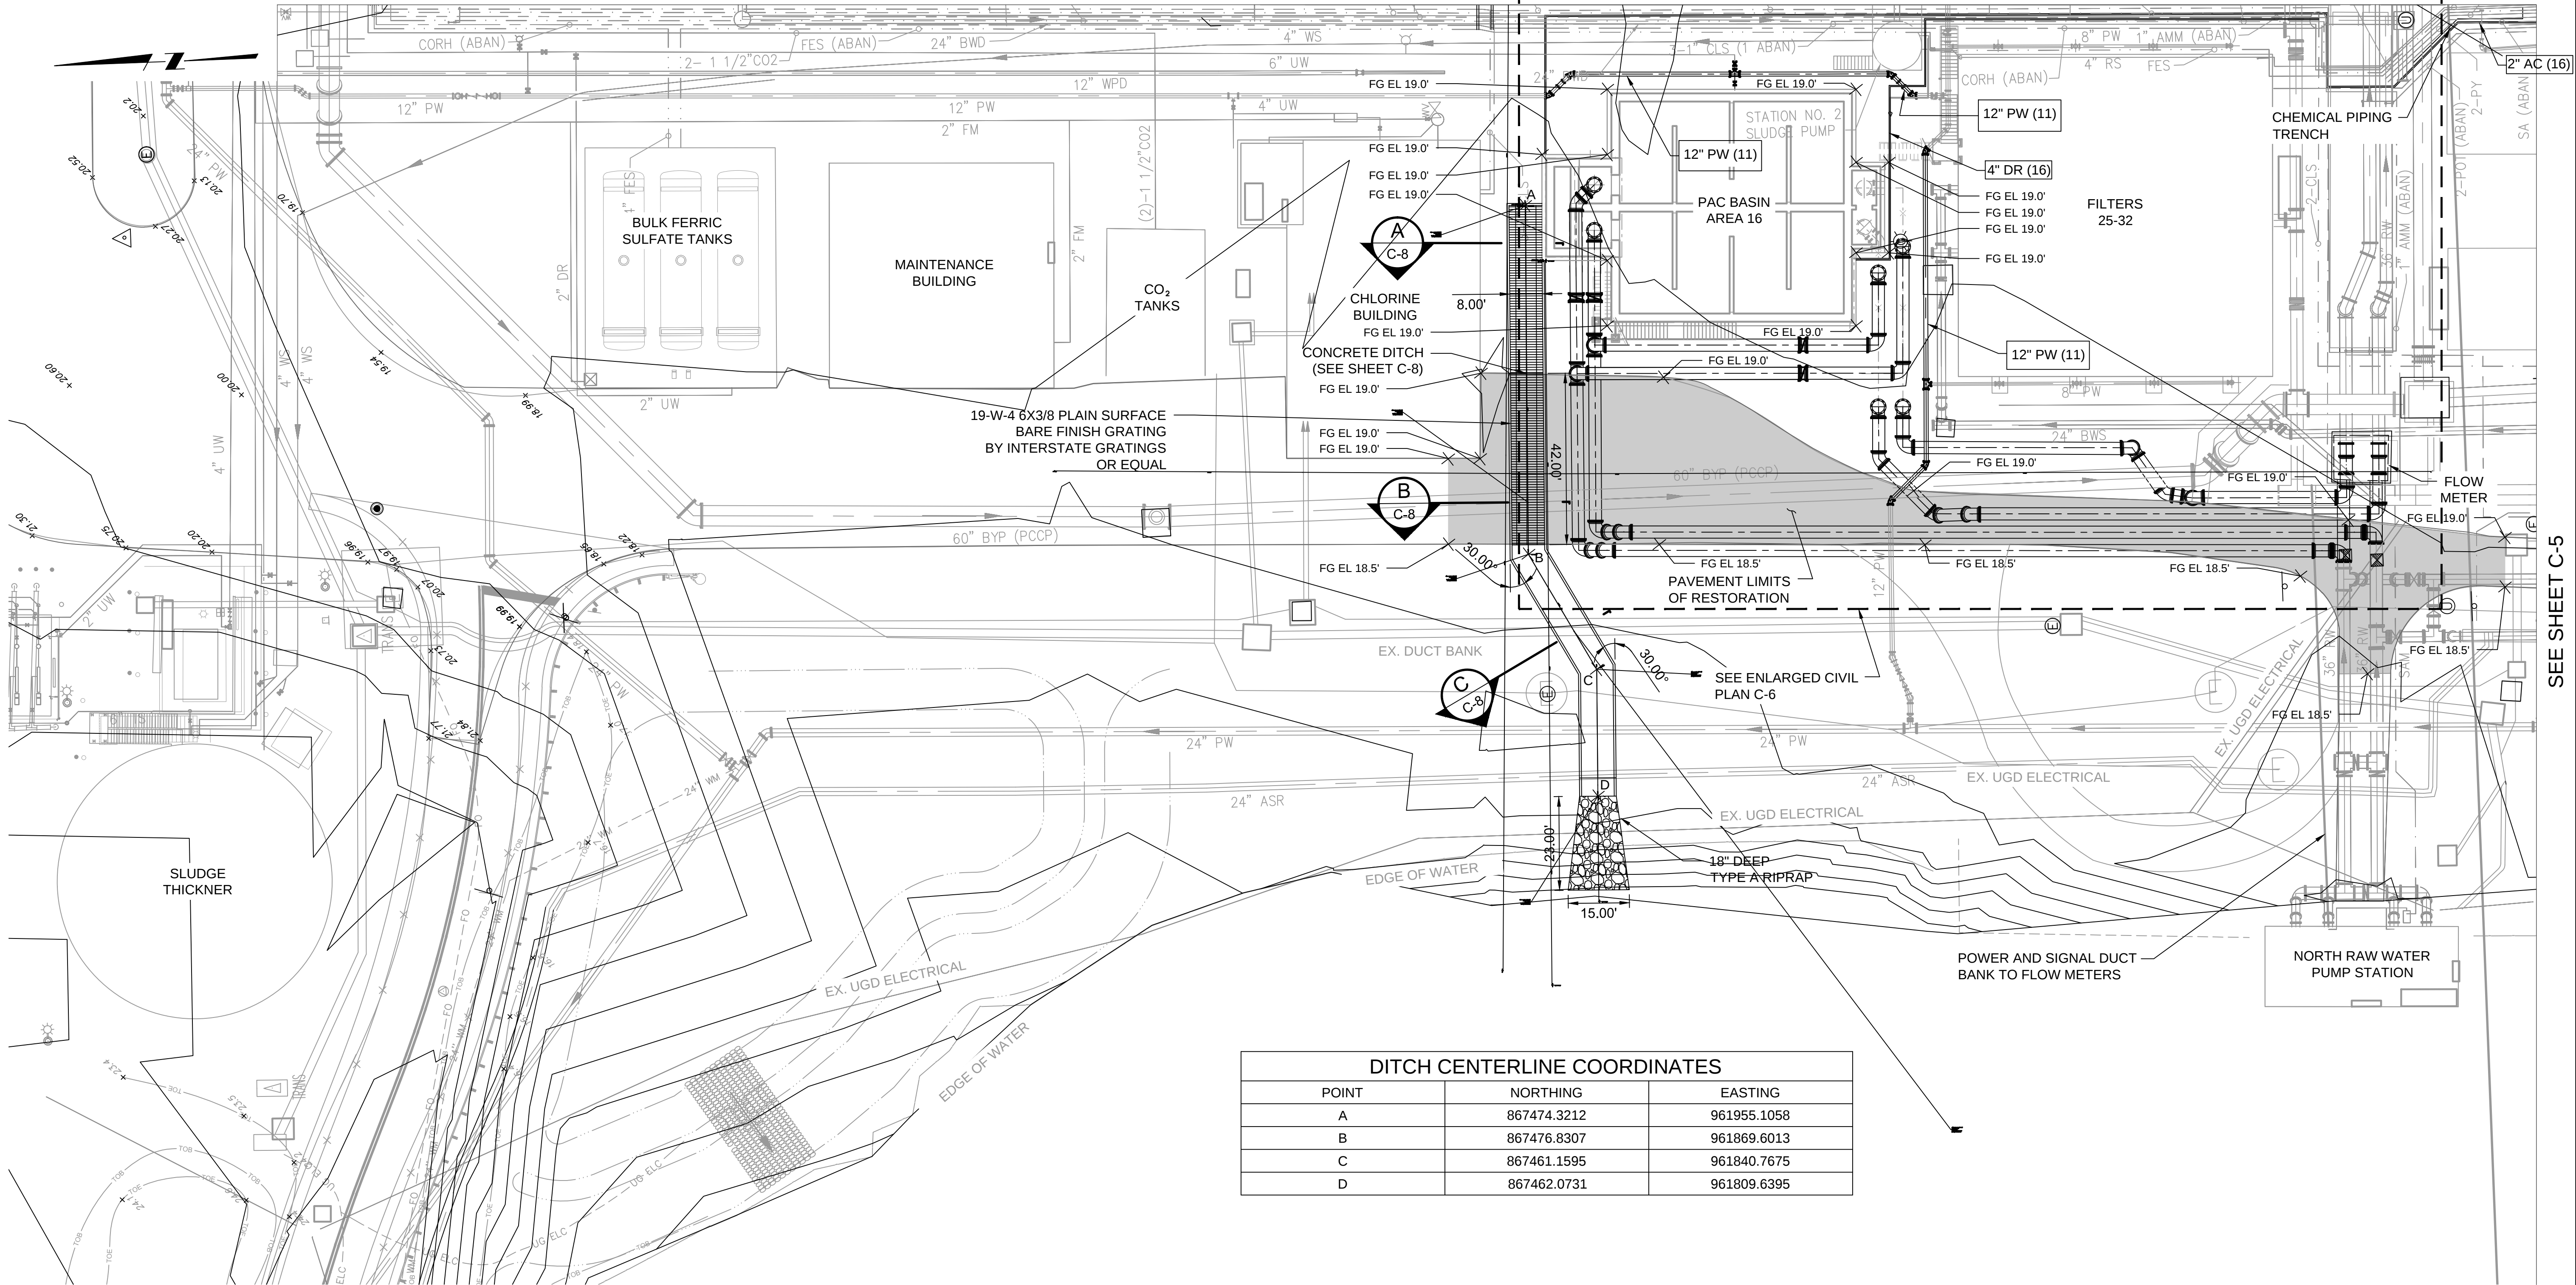

DITCH CENTERLINE COORDINATES		
POINT	NORTHING	EASTING
A	867474.3212	961955.1058
B	867476.8307	961869.6013
C	867461.1595	961840.7675
D	867462.0731	961809.6395

REV	DATE	BY	DESCRIPTION
1	NOV-2015	HRW	ISSUED FOR BID

SCALE

1"=20'

WARNING

IF THIS BAR DOES NOT MEASURE 1" THEN DRAWING IS NOT TO SCALE

DESIGNED H.WINTZ

DRAWN M.CARROLL

CHECKED J.ATKINSON

ISSUED FOR BID - NOVEMBER 2015

ANY PRINTS NOT BEARING THIS STAMP MAY HAVE BEEN PRINTED PRIOR TO ADVERTISING AND CANNOT BE CONSIDERED AS BID DOCUMENTS



MWH



CITY OF WEST PALM BEACH
Water Treatment Plant
1009 Banyan Boulevard
West Palm Beach, Florida 33401

Water Treatment Plant Improvements
PAC Treatment System and Settled Water Flume Modifications
CIVIL

SITE PIPING PLAN III

SHEET

C-4

10503313