




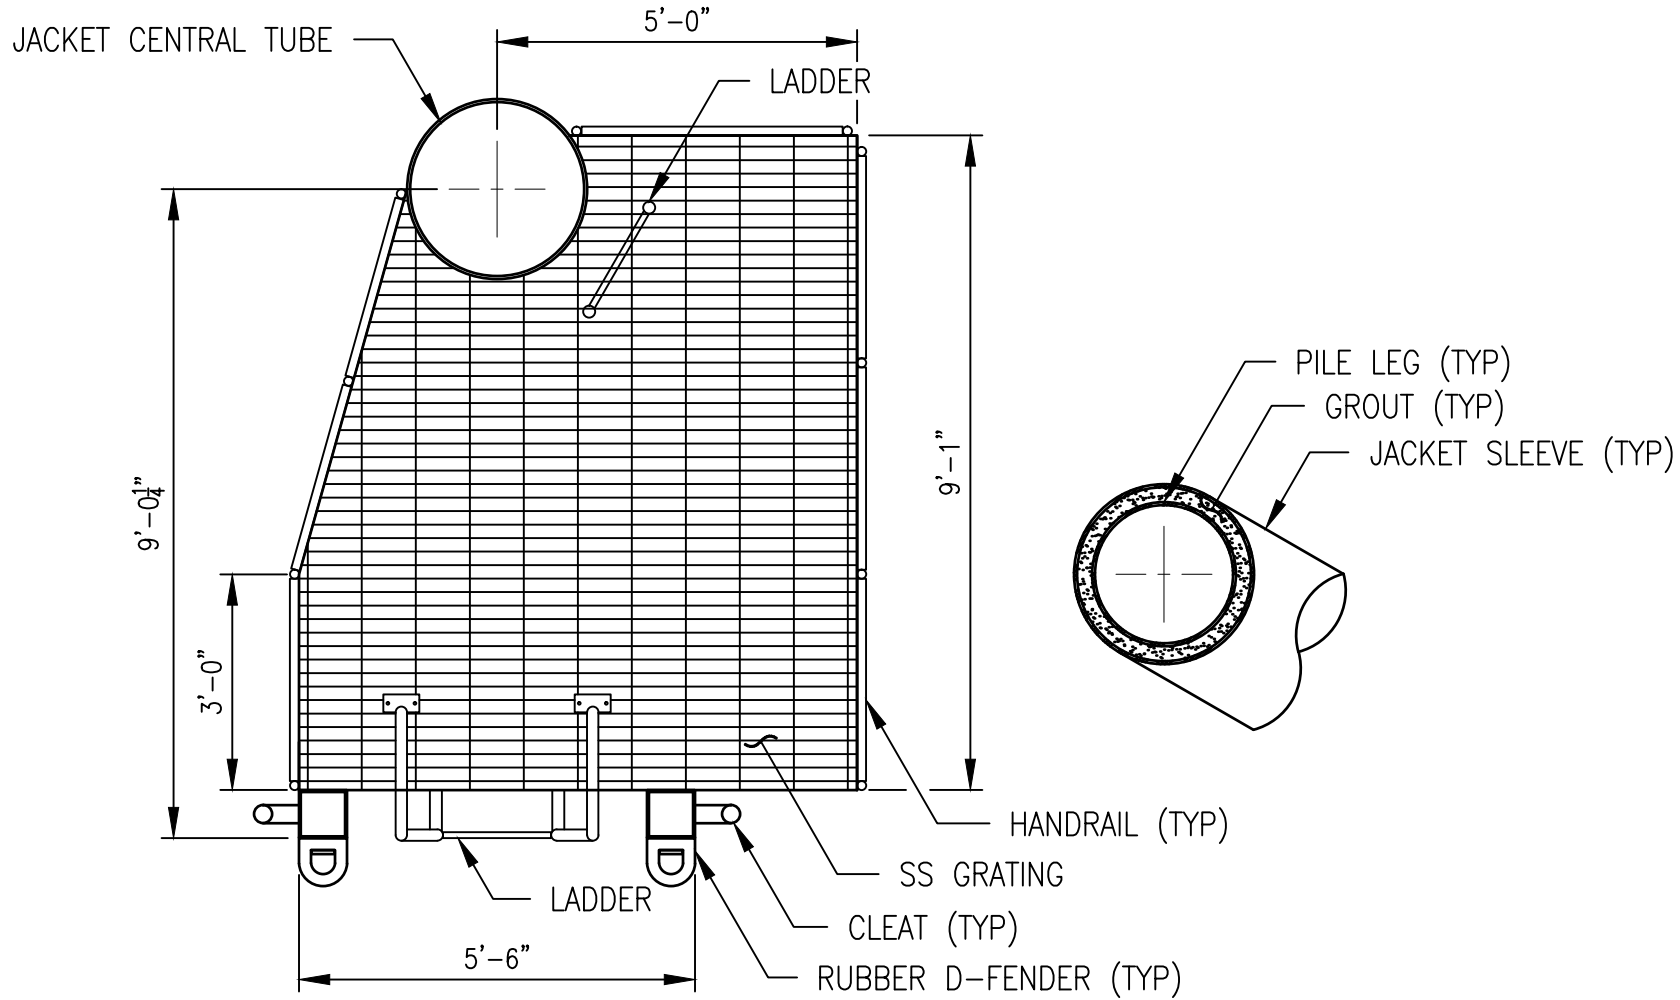


C1 BOAT LANDING DECK PLAN
SCALE: 3/8"=1'-0"

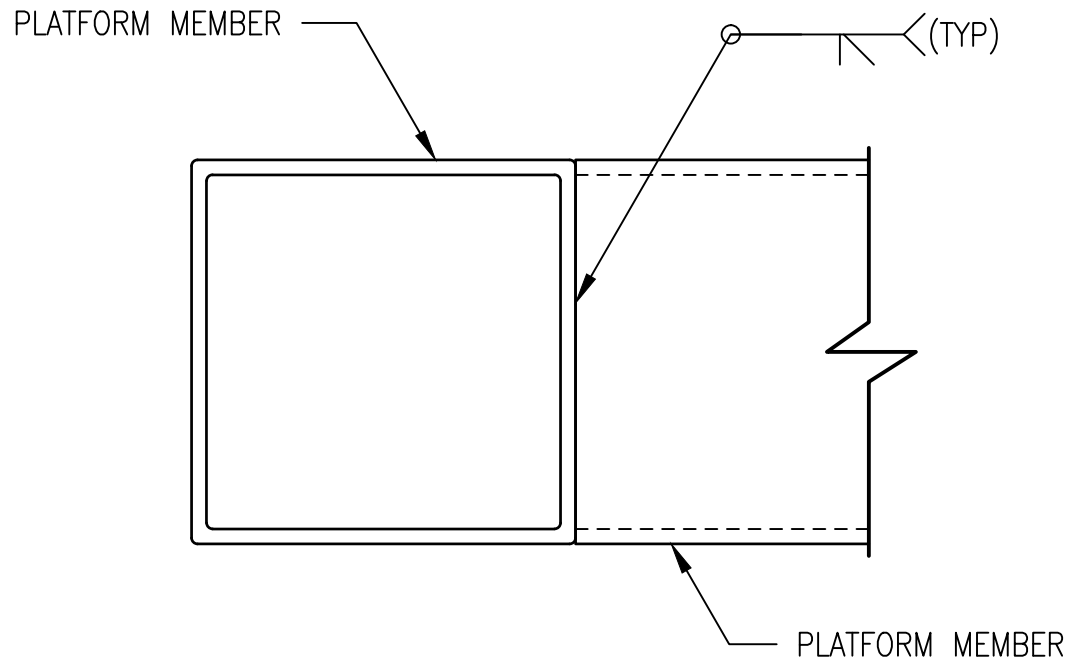


C3 PLATFORM CONNECTION DETAIL
SCALE: 3/8"=1'-0"

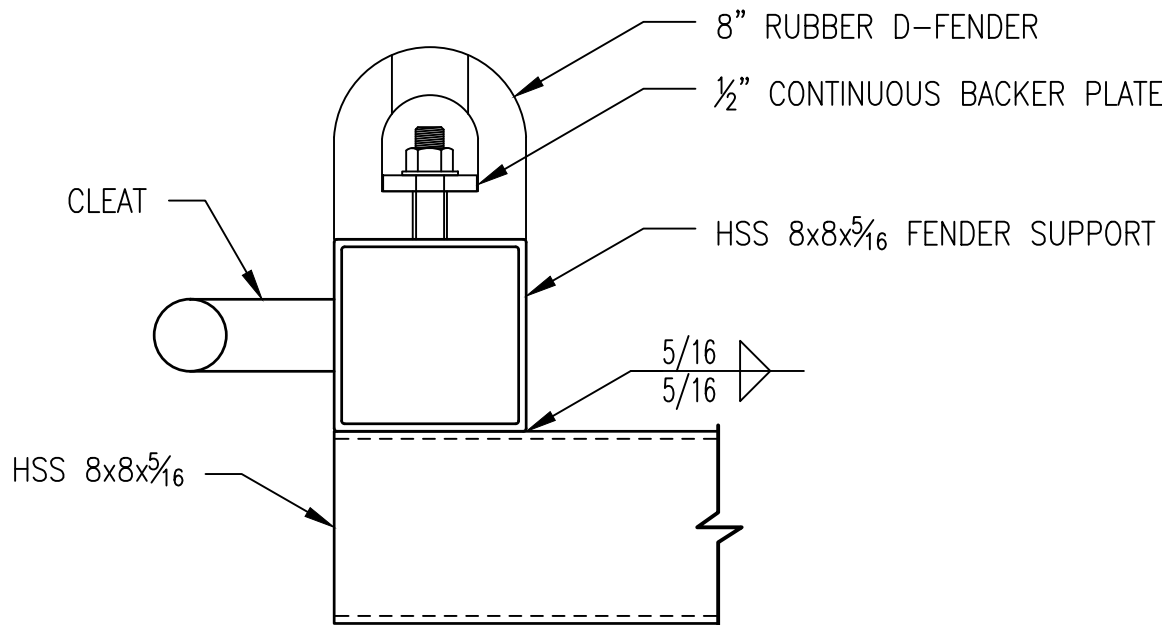

C4 FENDER CONNECTION DETAIL
SCALE: 1 1/2"=1'-0"

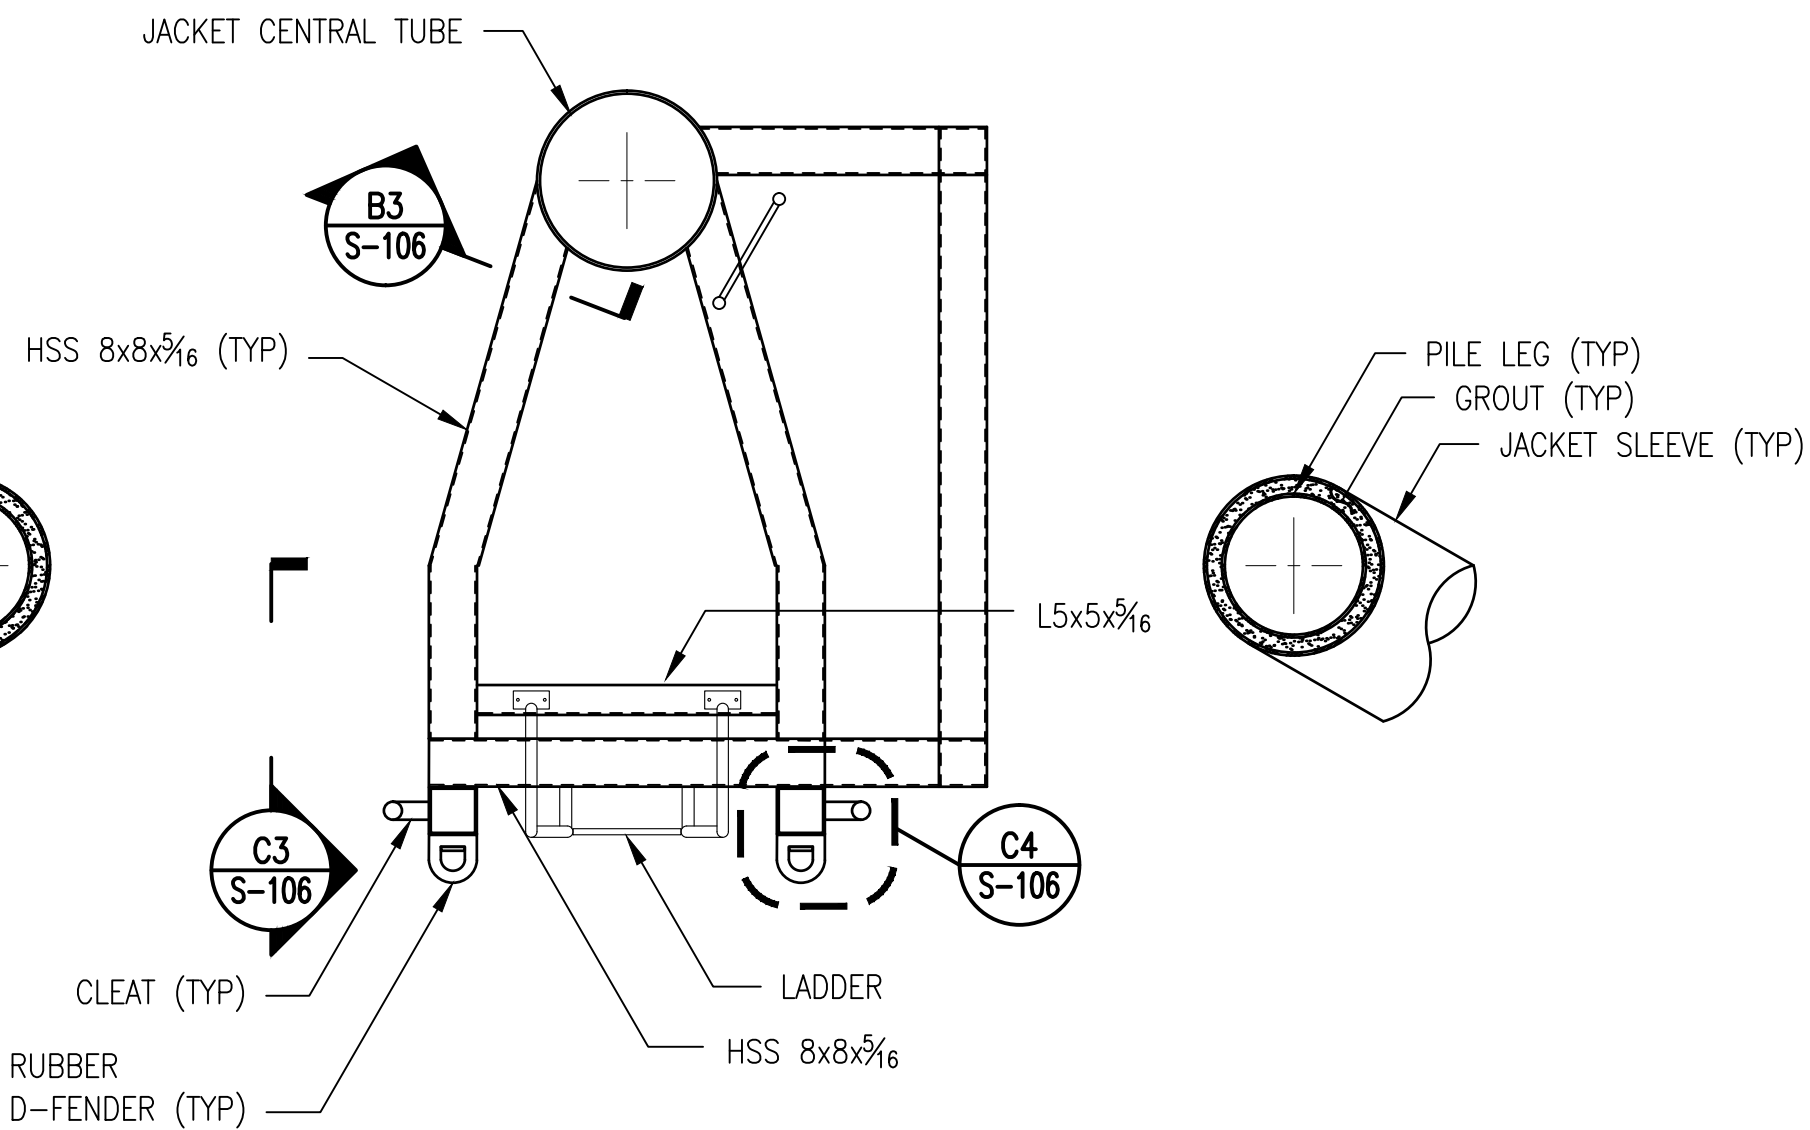

B1 BOAT LANDING FRAMING PLAN
SCALE: 3/8"=1'-0"

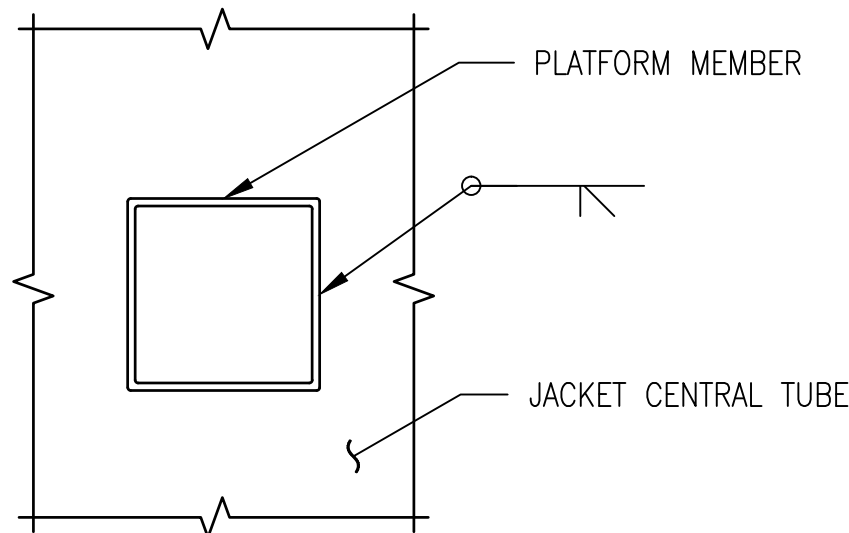

B3 CENTRAL TUBE CONNECTION DETAIL
SCALE: 1 1/2"=1'-0"


USCG CEU
CLEVELAND, OHIO
(216) 902-6200

CONSULTANTS
Appledore Marine Engineering, LLC
600 State Street, Suite E
Portsmouth, New Hampshire 03801
(603) 766-1870 inquiry@appledoremarine.com

wood. H2R
Joint Venture



U. S. COAST GUARD
CIVIL ENGINEERING UNIT
CLEVELAND

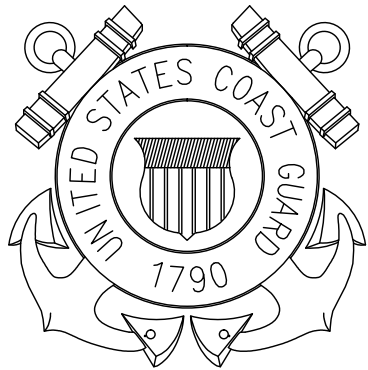

USCG. CEU CLEVELAND
1240 EAST 9TH STREET
CLEVELAND, OH 44199-2060

ISSUE		
0	3/31/2021	ISSUED FOR BID
MARK	DATE	DESCRIPTION

A/E PROJECT NO: 9022
CAD FILE NAME: C8568S106.DWG
DESIGNED BY: KMV
DRAWN BY: SND
EDITED BY: KMV
CHECKED BY: LAH

SCALE: AS SHOWN PLOT SCALE: 1:1

SHEET TITLE

REBUILD NEW CASTLE RANGE LIGHTS
USCG ANT PHILADELPHIA
PHILADELPHIA PA
LLNR 2730
STRUCTURAL
RFL BOAT LANDING DETAILS

REVIEWED BY: D.G. WARD	REVIEWED BY: B. VRANKAR	REVIEWED BY: G. LODGE
PROJECT ENG.	BRANCH CHIEF	TECH. DIRECTOR

J.M. HALL CDR APPROVING OFFICER	31MAR21 DATE
------------------------------------	-----------------

PROJECT NUMBER	DRAWING NUMBER
05-C04223	8568-D
DISCIPLINE/SHT NO	SHEET 14 OF 36
S-106	